

REINSTATEMENT WORKS: LEVEL 2, 5 FLEET PLACE, LONDON  
REFLECTED CEILING PLAN AS PROPOSED: LEVEL 2 LIFT LOBBY

NEW SERVICES (shown coloured):


LIGHTING (coloured yellow):  
2 x circular lights to match existing:  
Reference: LTS PL21 semi recessed  
pendant luminaire.  
Manufacturer/Supplier: LTS, Germany:  
Web Link:  
<https://www.lts-light.eu/lts-products.html?seite=type&bereichId=6&wgr=1719&Ty pe=PL+20.900>  
Size: 900mm diameter


Extend light track recess in ceiling and  
install 3 x twin spotlights:  
Supplier: Luxoworks  
Type: Deltalight on Minigrd 2 x 50W  
Product Code: 202-77-55-02W  
Web Link: <https://www.luxoworks.com/en/database/deltalight/202-77-55-02-w/>  
Install 1 x light sensor (LS)

FIRE PROTECTION (coloured red):  
1 x Smoke Detector (SD)

2 x sprinkler heads (SP) with new  
pipework connected to existing to  
reinstate as shown on as built  
drg ref: 18867200-063-FE02-Z

HVAC (coloured blue):  
1 x vent and cover grille in ceiling to  
be ducted from existing FCU in  
ceiling void adjacent to access  
hatch: see DSM Air Conditioning Ltd  
drawing no M001 dated Dec09.

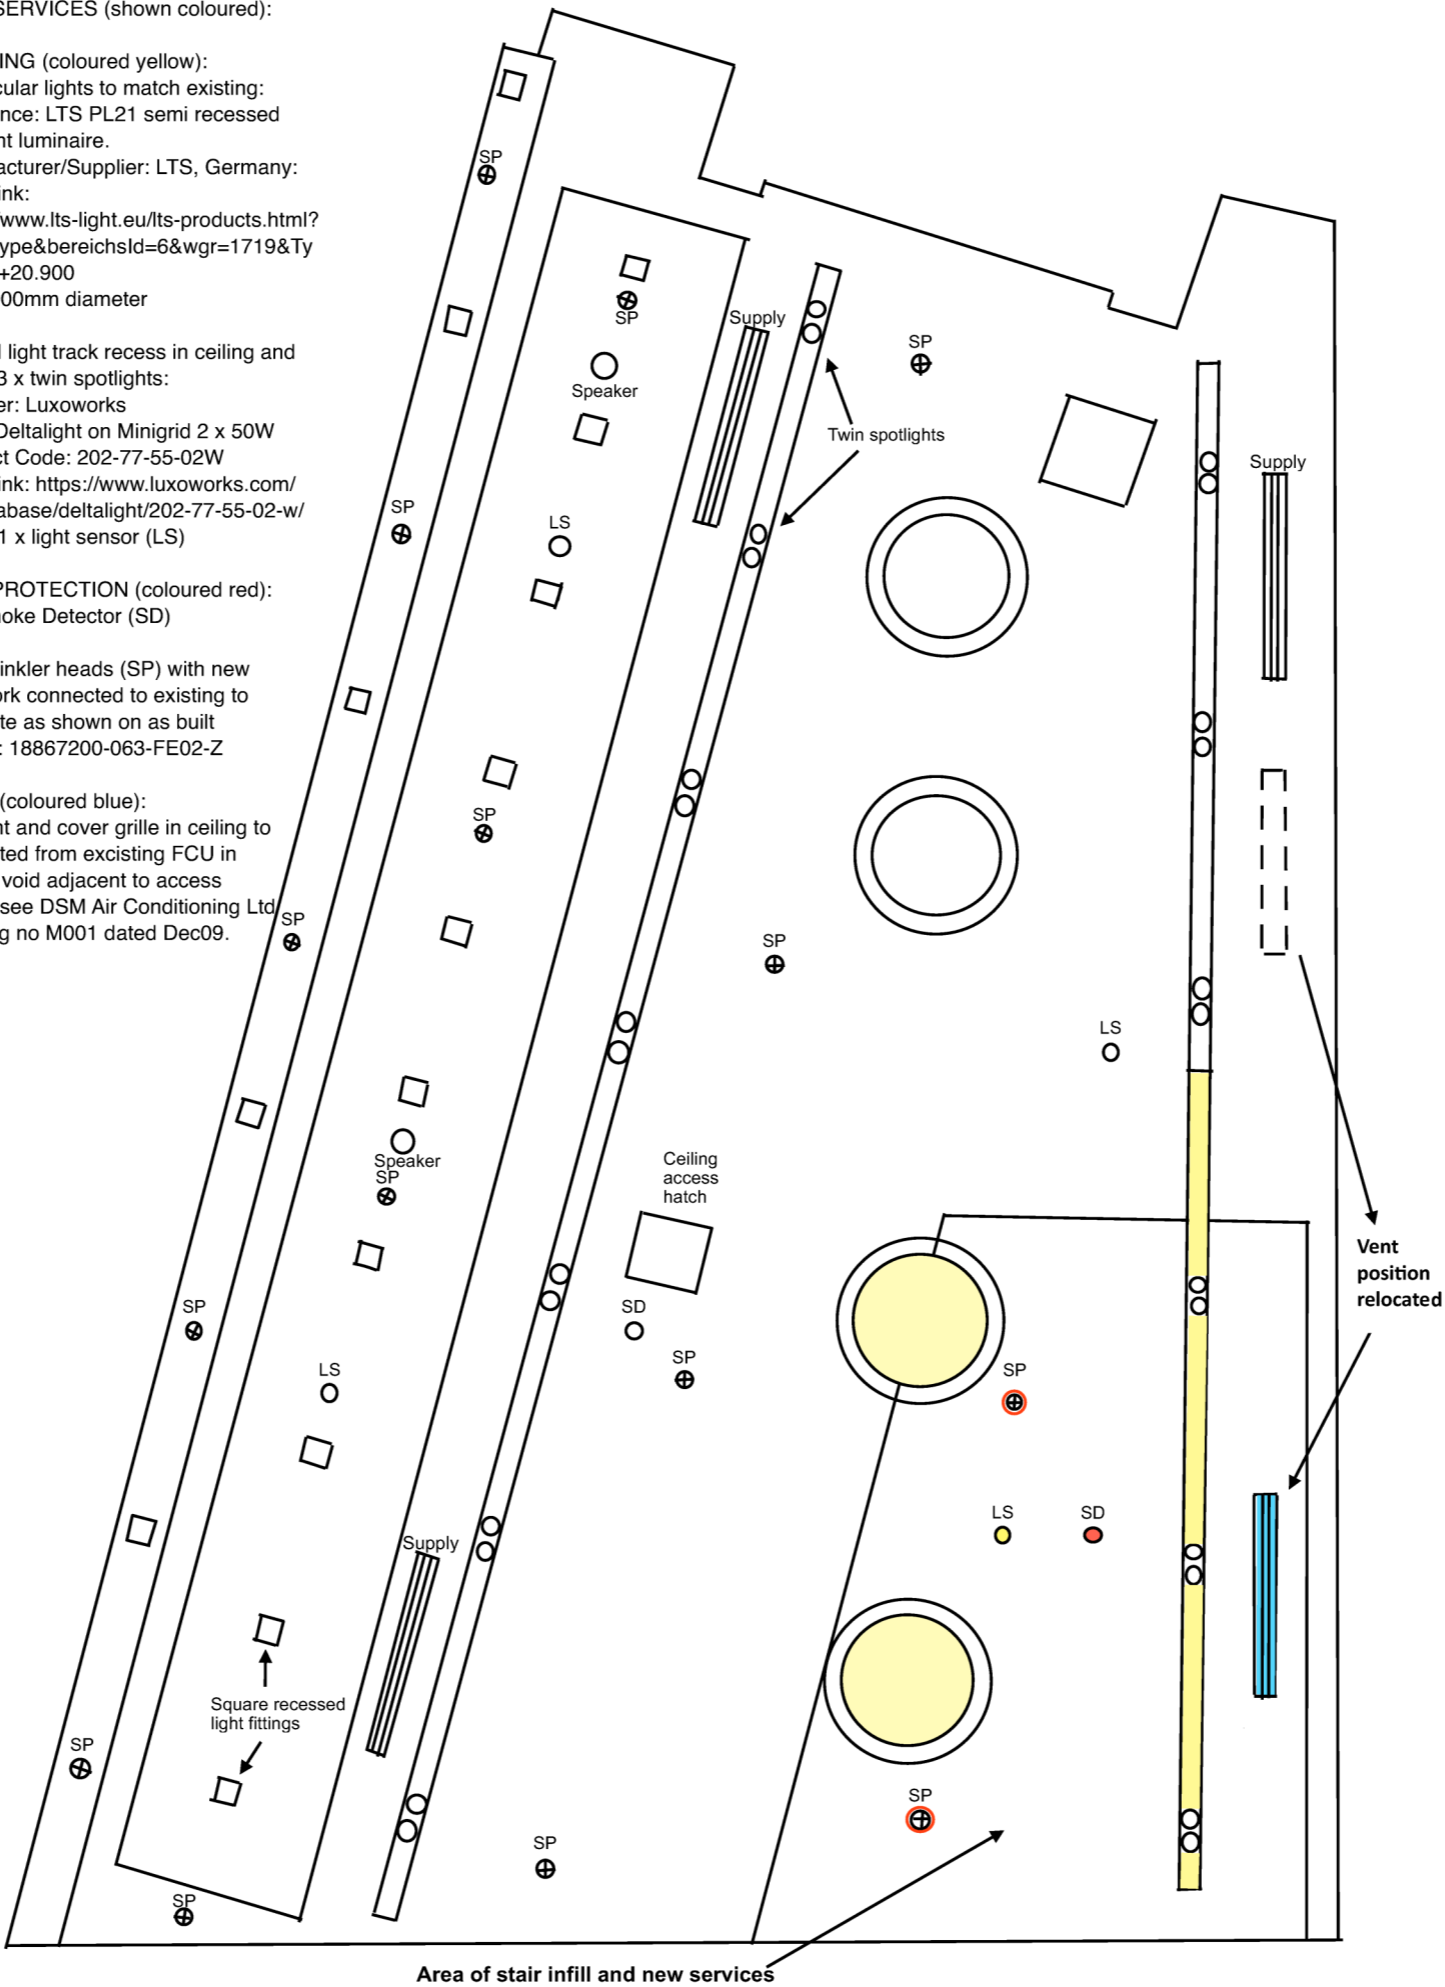

REVISIONS		INDEX	DATE
<p><u>DO NOT SCALE FROM DRAWINGS.</u> ALL DIMENSIONS GIVEN SHOULD BE VERIFIED ON SITE. ANY DISCREPANCIES SHOULD BE REPORTED TO THE SURVEYOR BEFORE WORK IS PUT IN HAND. DRAWINGS MAY NOT BE REPRODUCED WITHOUT PRIOR CONSENT FROM HENDERSON SURVEYING LTD</p>			
<div><div></div><div><h1>HENDERSON</h1><p>SURVEYING LIMITED</p><p>95 Ditchling Road, Brighton BN1 4ST</p><p>Tel: 01273 573889 www.hendersonsurveying.com</p><p>Managing Director: Ian A Henderson DipBS MRICS MCIArb Mobile: 07793 089826</p></div></div>			
<p>PROPERTY</p> <p>Levels 2 &amp; 3, 5 Fleet Place, London EC4M 7RD</p>			
<p>DRAWING TITLE</p> <p>Staircase Removal &amp; Reinstatement Works</p>			
<p>SCALE</p> <p>1:50 @ A3</p>			
<p>DRAWN BY</p> <p>IH</p>		<p>DATE</p> <p>13 March 2017</p>	
<p>CHECKED BY</p> <p>IH</p>		<p>DATE</p> <p>13 March 2017</p>	
<p>DRAWING No.</p> <p>E1582-07</p>			